


밀레니엄관 계통도면(16.02.23)

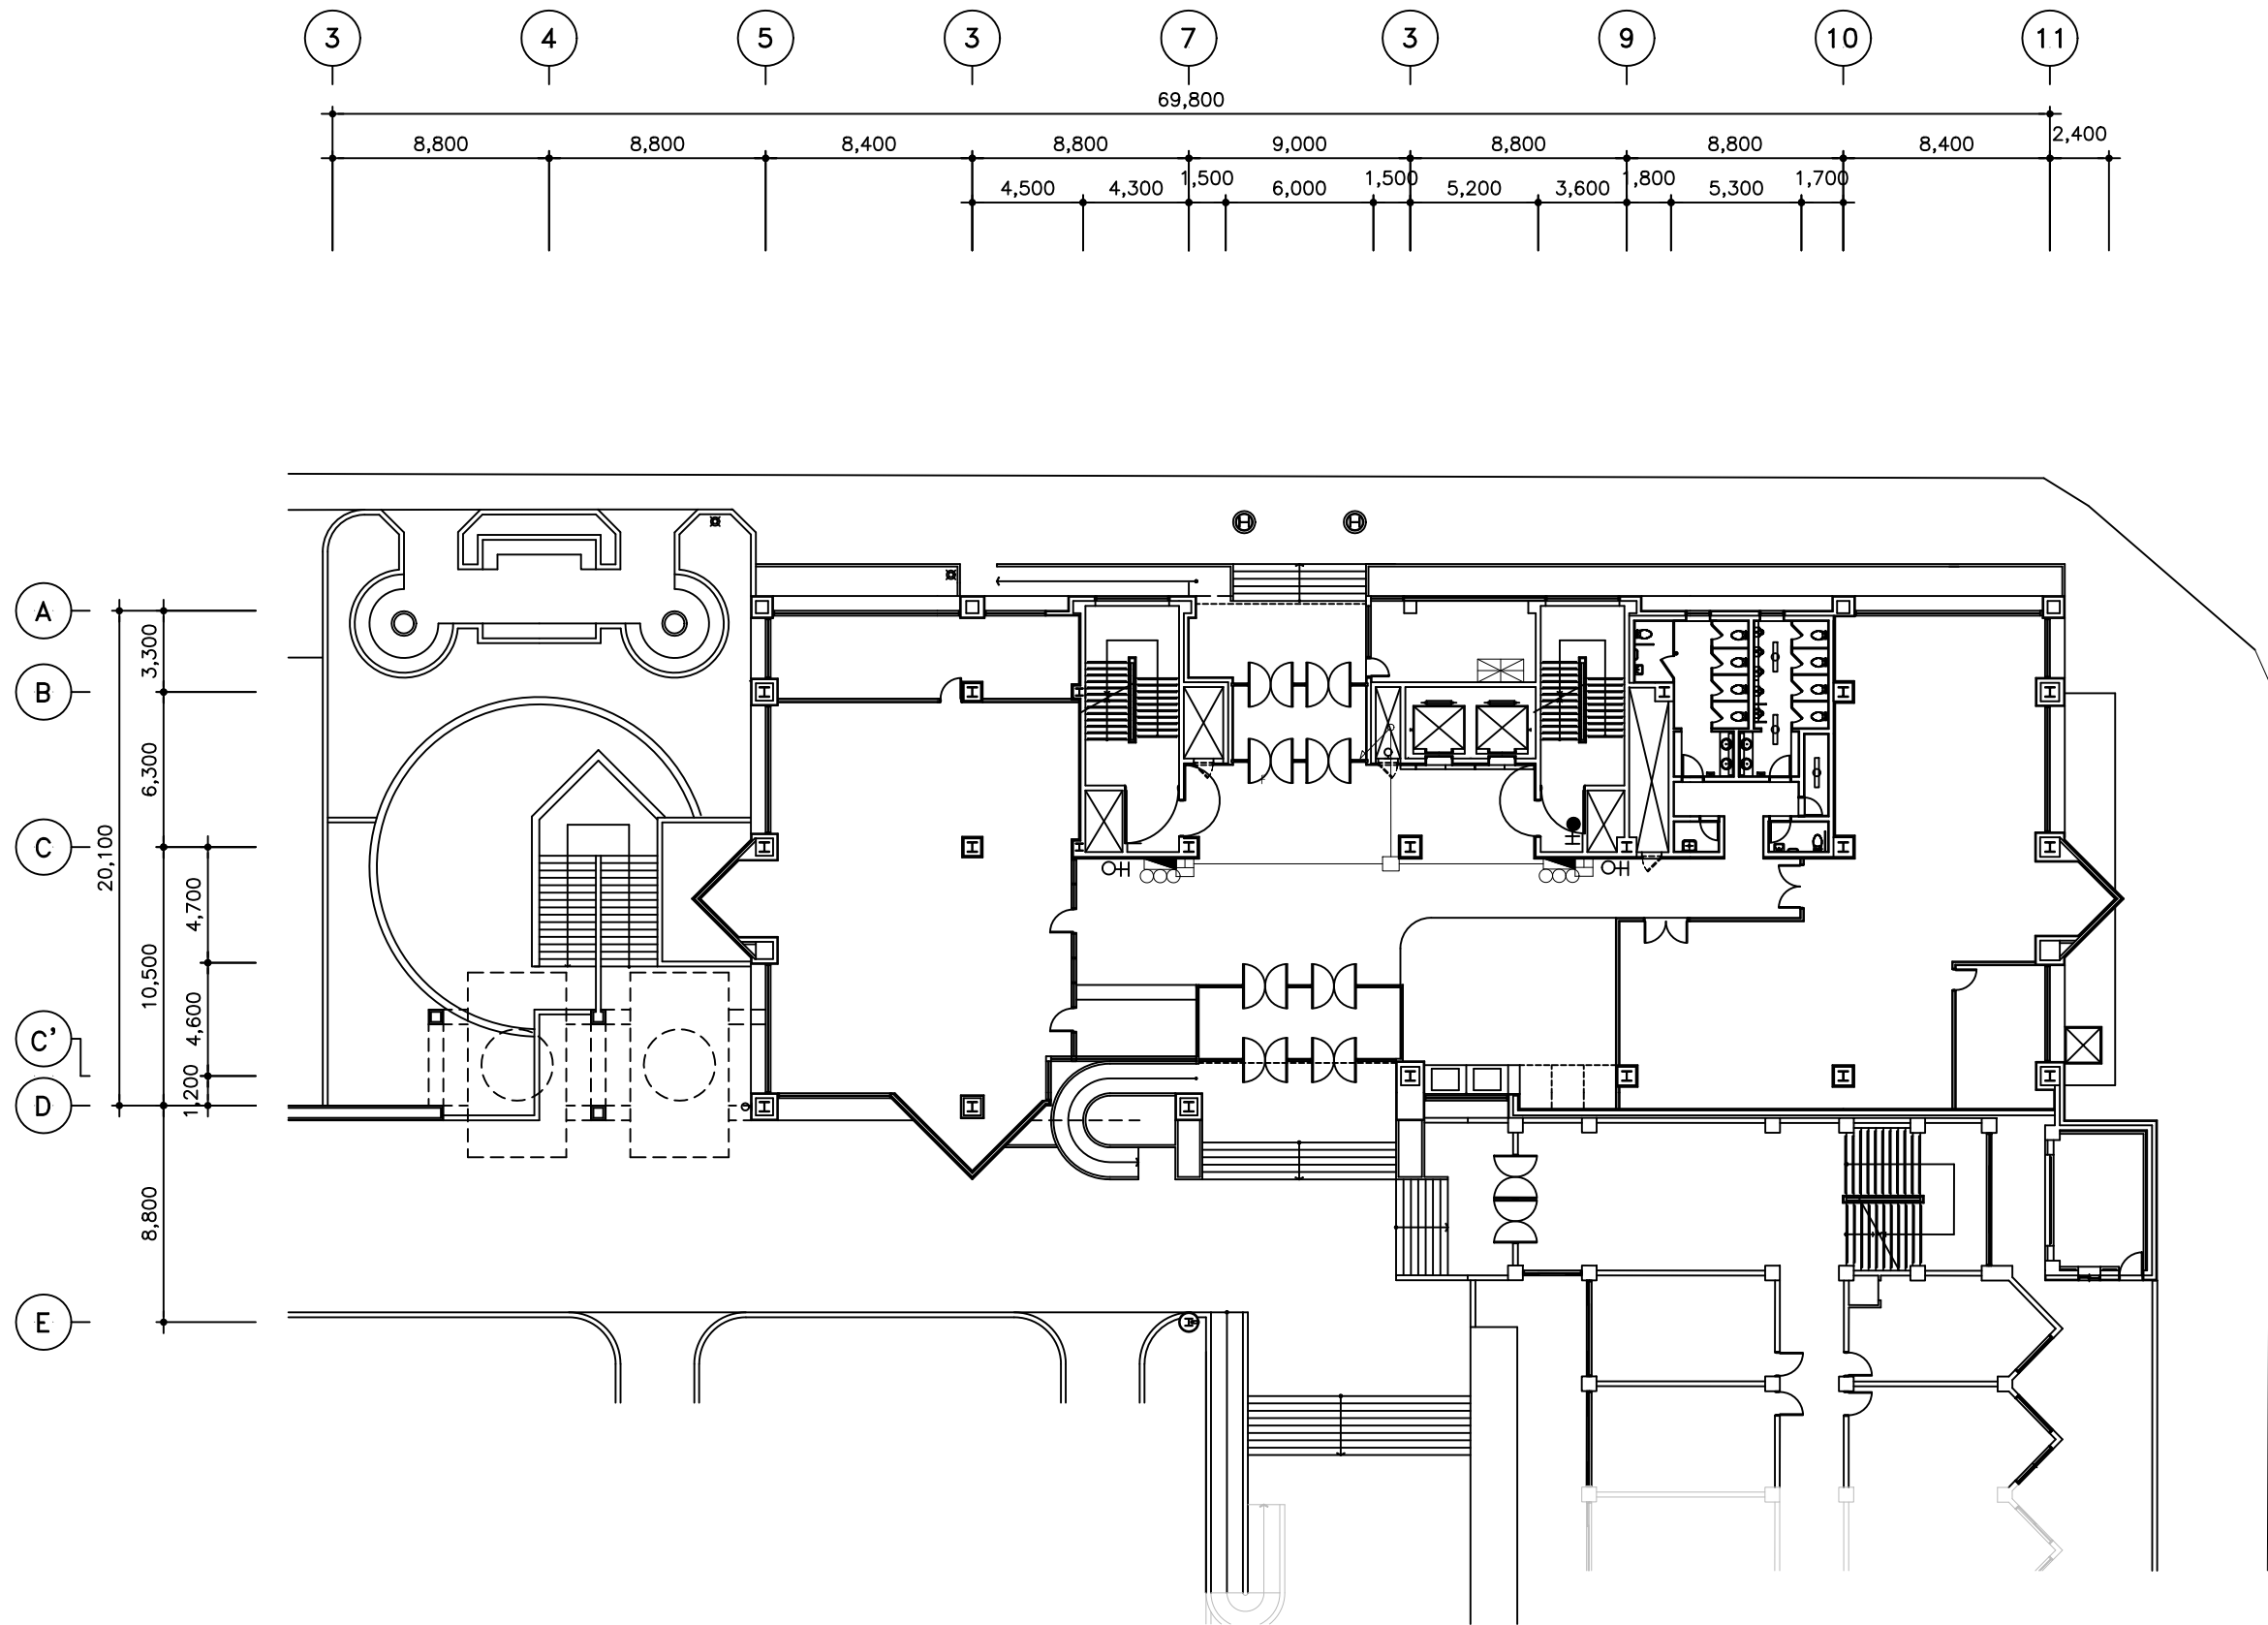

1층 자동화재탐지 설비 평면도  
축척 : 1/150

설계명  
PROJECT TITLE

설계번호  
PROJECT NO.

특기사항  
NOTES

변경  
REVISION

제도  
DRAWN BY  
검토  
CHECKED BY  
설계  
DESIGNED BY  
승인  
APPROVED BY

도면명  
NAME OF DRAWING

1층 자동화재탐지 설비 평면도

축척  
SCALE

1/150

날짜  
DATE

04.05

도면번호  
DRAWING NO.




EF-01

일련번호  
SHEET NO.

# 시공상세도

J BOX  
STEEL PIPE 16C  
F/CB 4SQ\*3C

J/BOX 열선3M  
콘센트

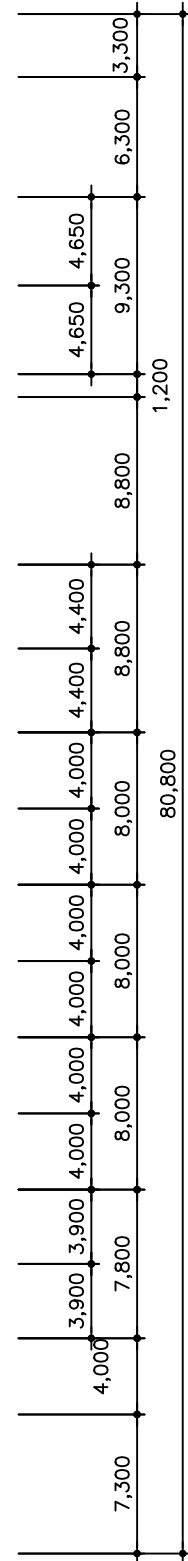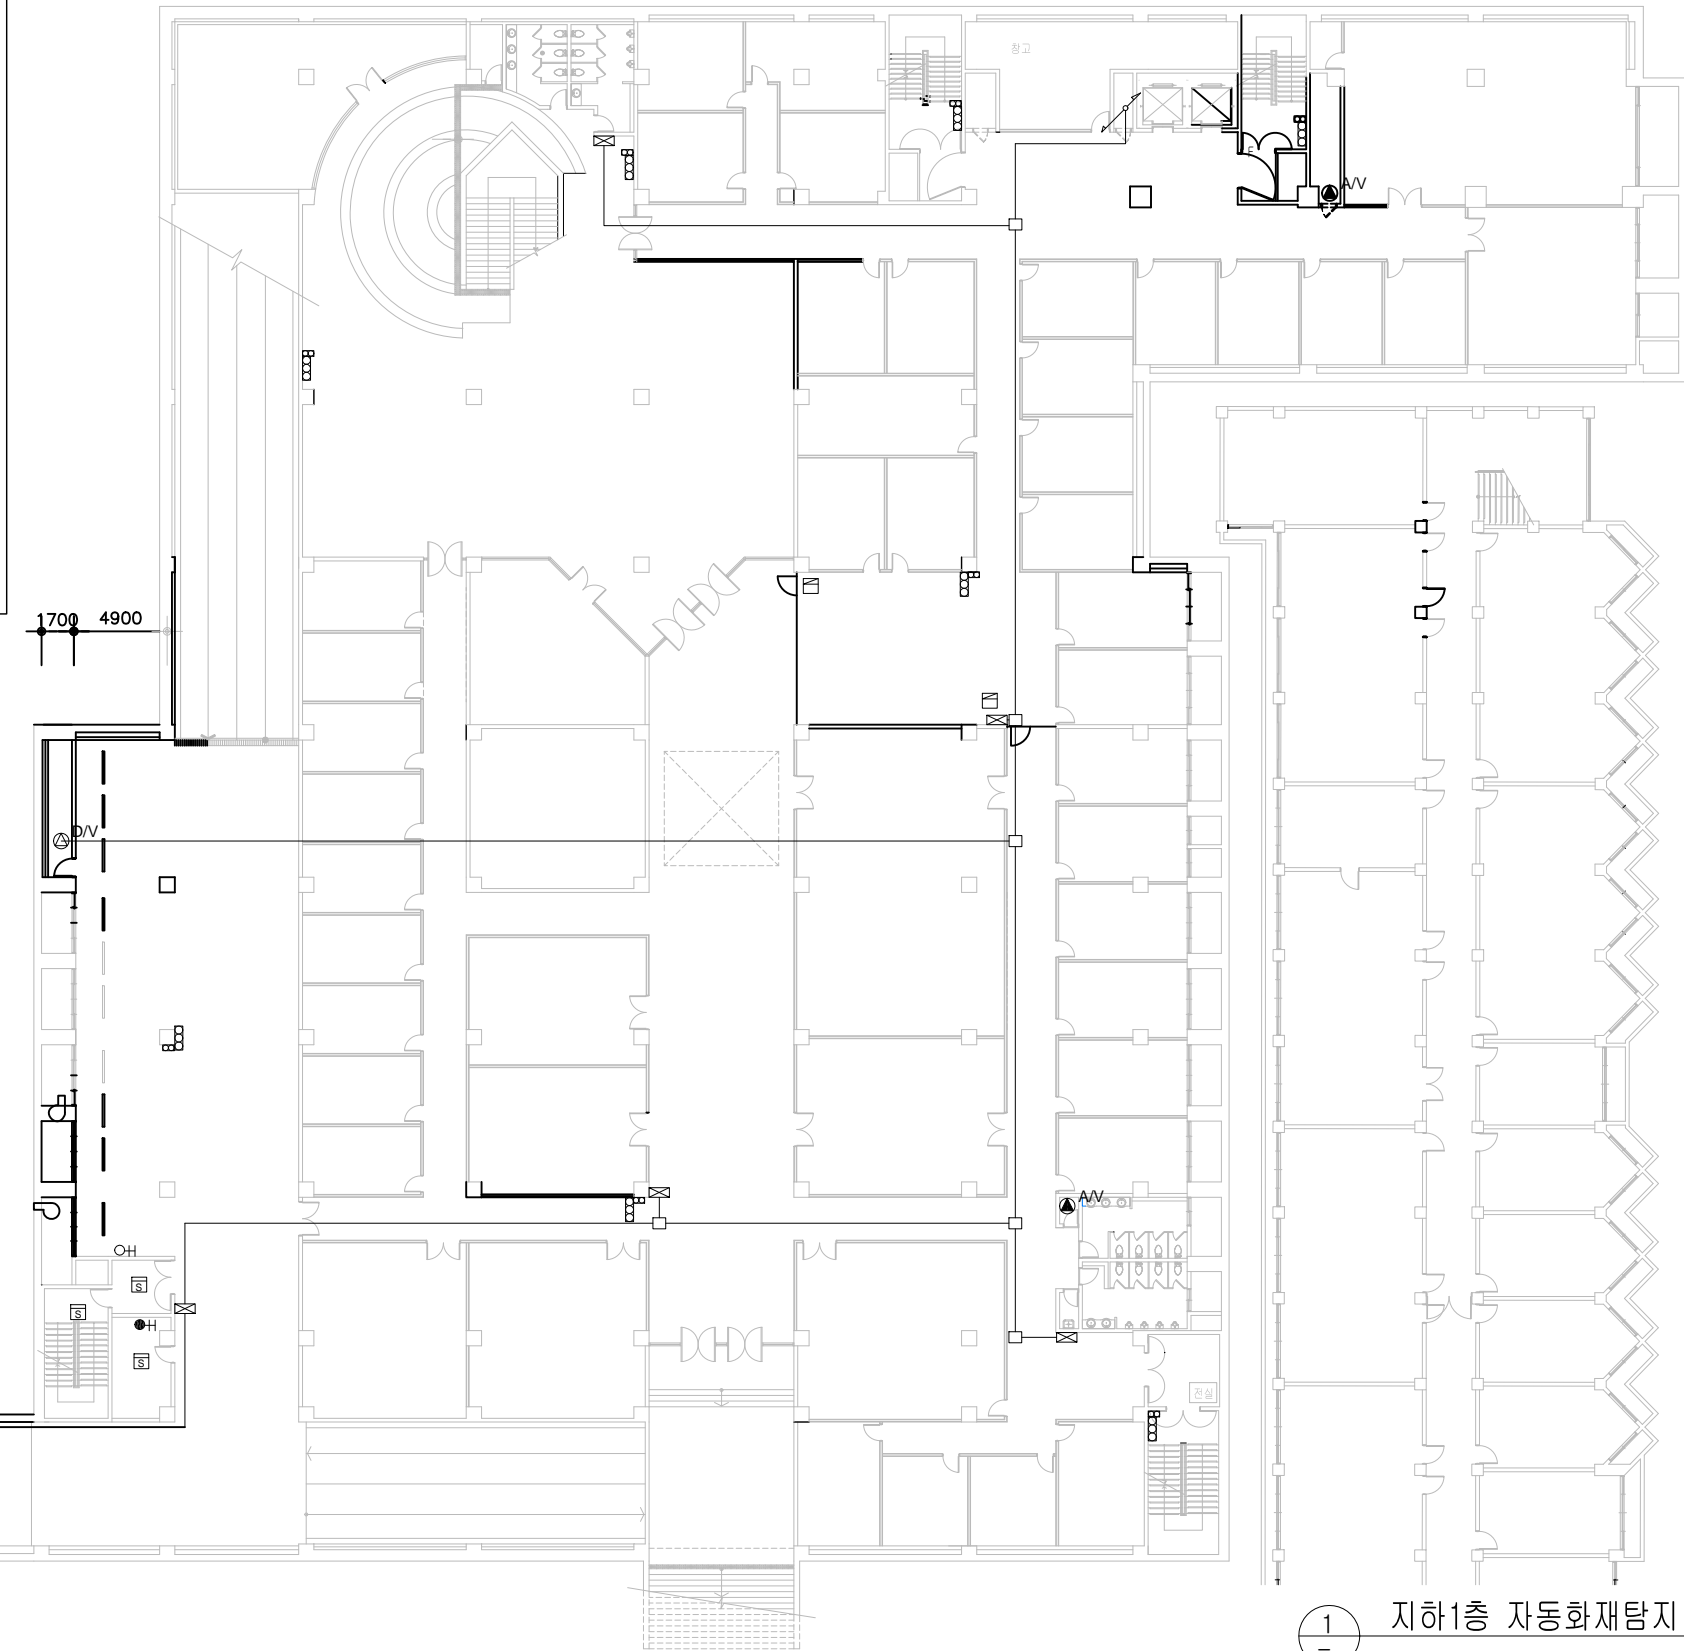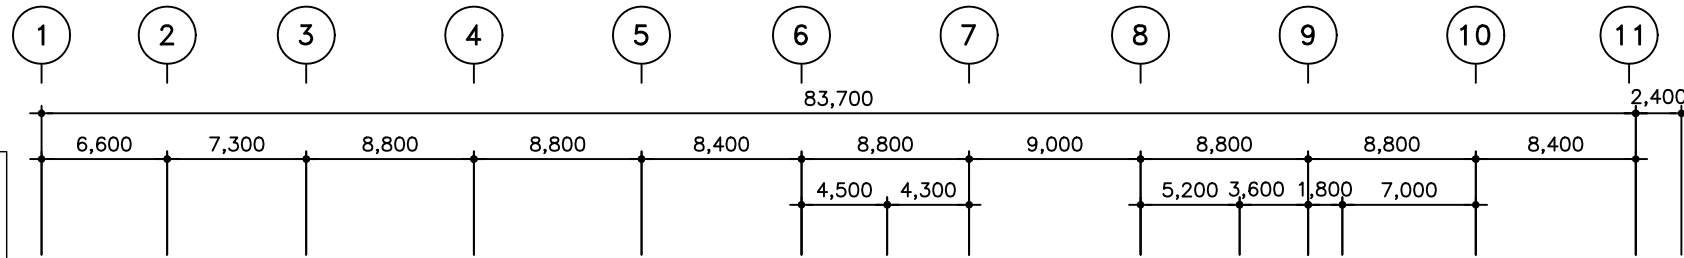

설 계 명

부천대학 00관  
신 축 공 사

설 계 번 호

PROJECT NO.

특 기 사 항

NOTES

변 경

REVISION

제 도

DRAWN BY

검 토

CHECKED BY

설 계

DESIGNED BY

승 인

APPROVED BY

도 면 명

NAME OF DRAWING

지하1층 자동화재탐지 설비 평면도

축척

SCALE

1/200

날짜

DATE

04.05

도면번호



DRAWING NO.

EF - 02

일련번호

SHEET NO.

# 시공상세도

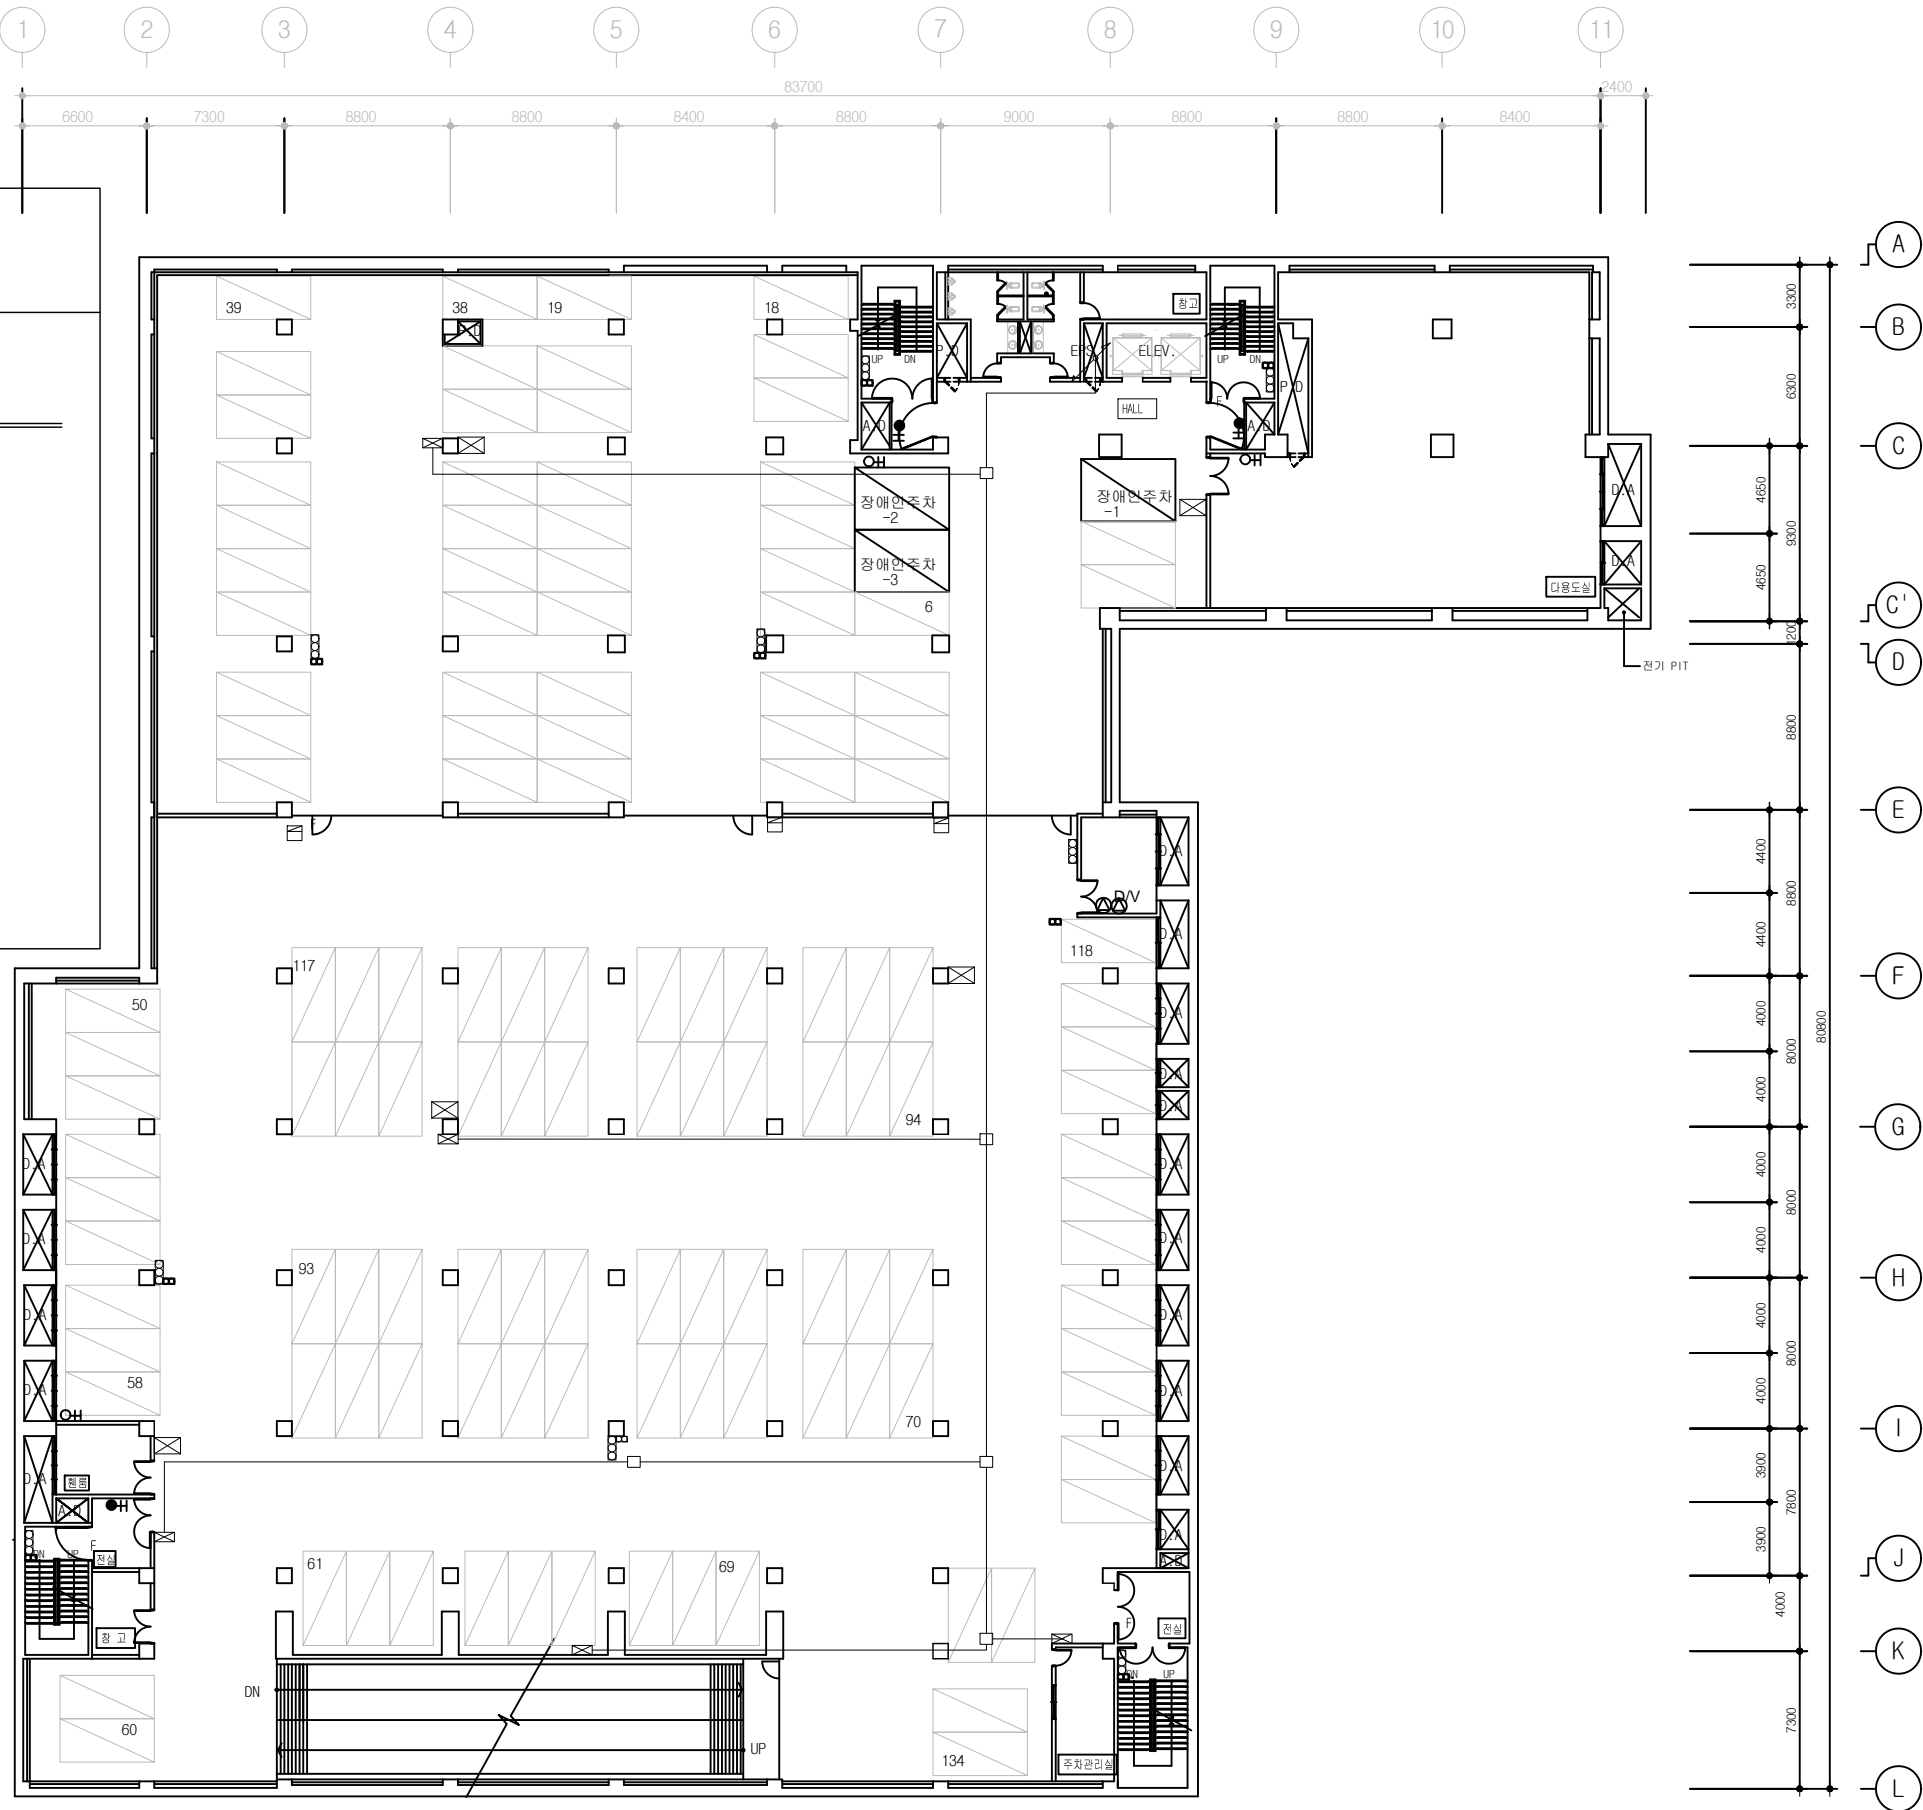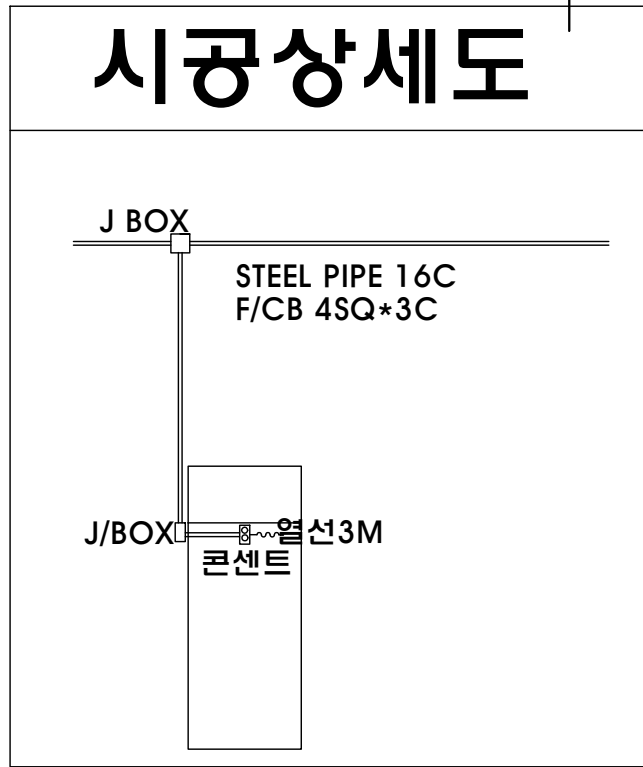

1 지하2층 자동화재탐지 설비 평면도  
축척 : 1/200

설계명  
PROJECT TITLE

설계번호  
PROJECT NO.

특기사항  
NOTES

변경  
REVISION

제출  
DRAWN BY  
검토  
CHECKED BY  
설계  
DESIGNED BY  
승인  
APPROVED BY

도면명  
NAME OF DRAWING

지하2층 자동화재탐지 설비 평면도

축척  
SCALE  
1/200

날짜  
DATE  
04.05

도면번호  
DRAWING NO.  
EF - 03

일련번호  
SHEET NO.


# 시공상세도

The diagram illustrates a vertical steel pipe assembly. At the top, a horizontal line represents a ceiling or floor structure, with a square symbol indicating the pipe's entry point, labeled "J BOX". The vertical pipe is labeled "STEEL PIPE 16C" and "F/CB 45Q\*3C". The pipe extends downwards and terminates in a rectangular box labeled "콘센트" (Outlet). A horizontal line, labeled "열선3M" (Heating wire 3M), is shown passing through the outlet box. The connection point between the vertical pipe and the outlet box is labeled "J/BOX".

J BOX

STEEL PIPE 16C  
F/CB 45Q\*3C

 J/BOX 열선3M  
콘센트

[illegible]